


REVISIONS			
REV	DESCRIPTION	BY	DATE
A	INITIAL REVISION		

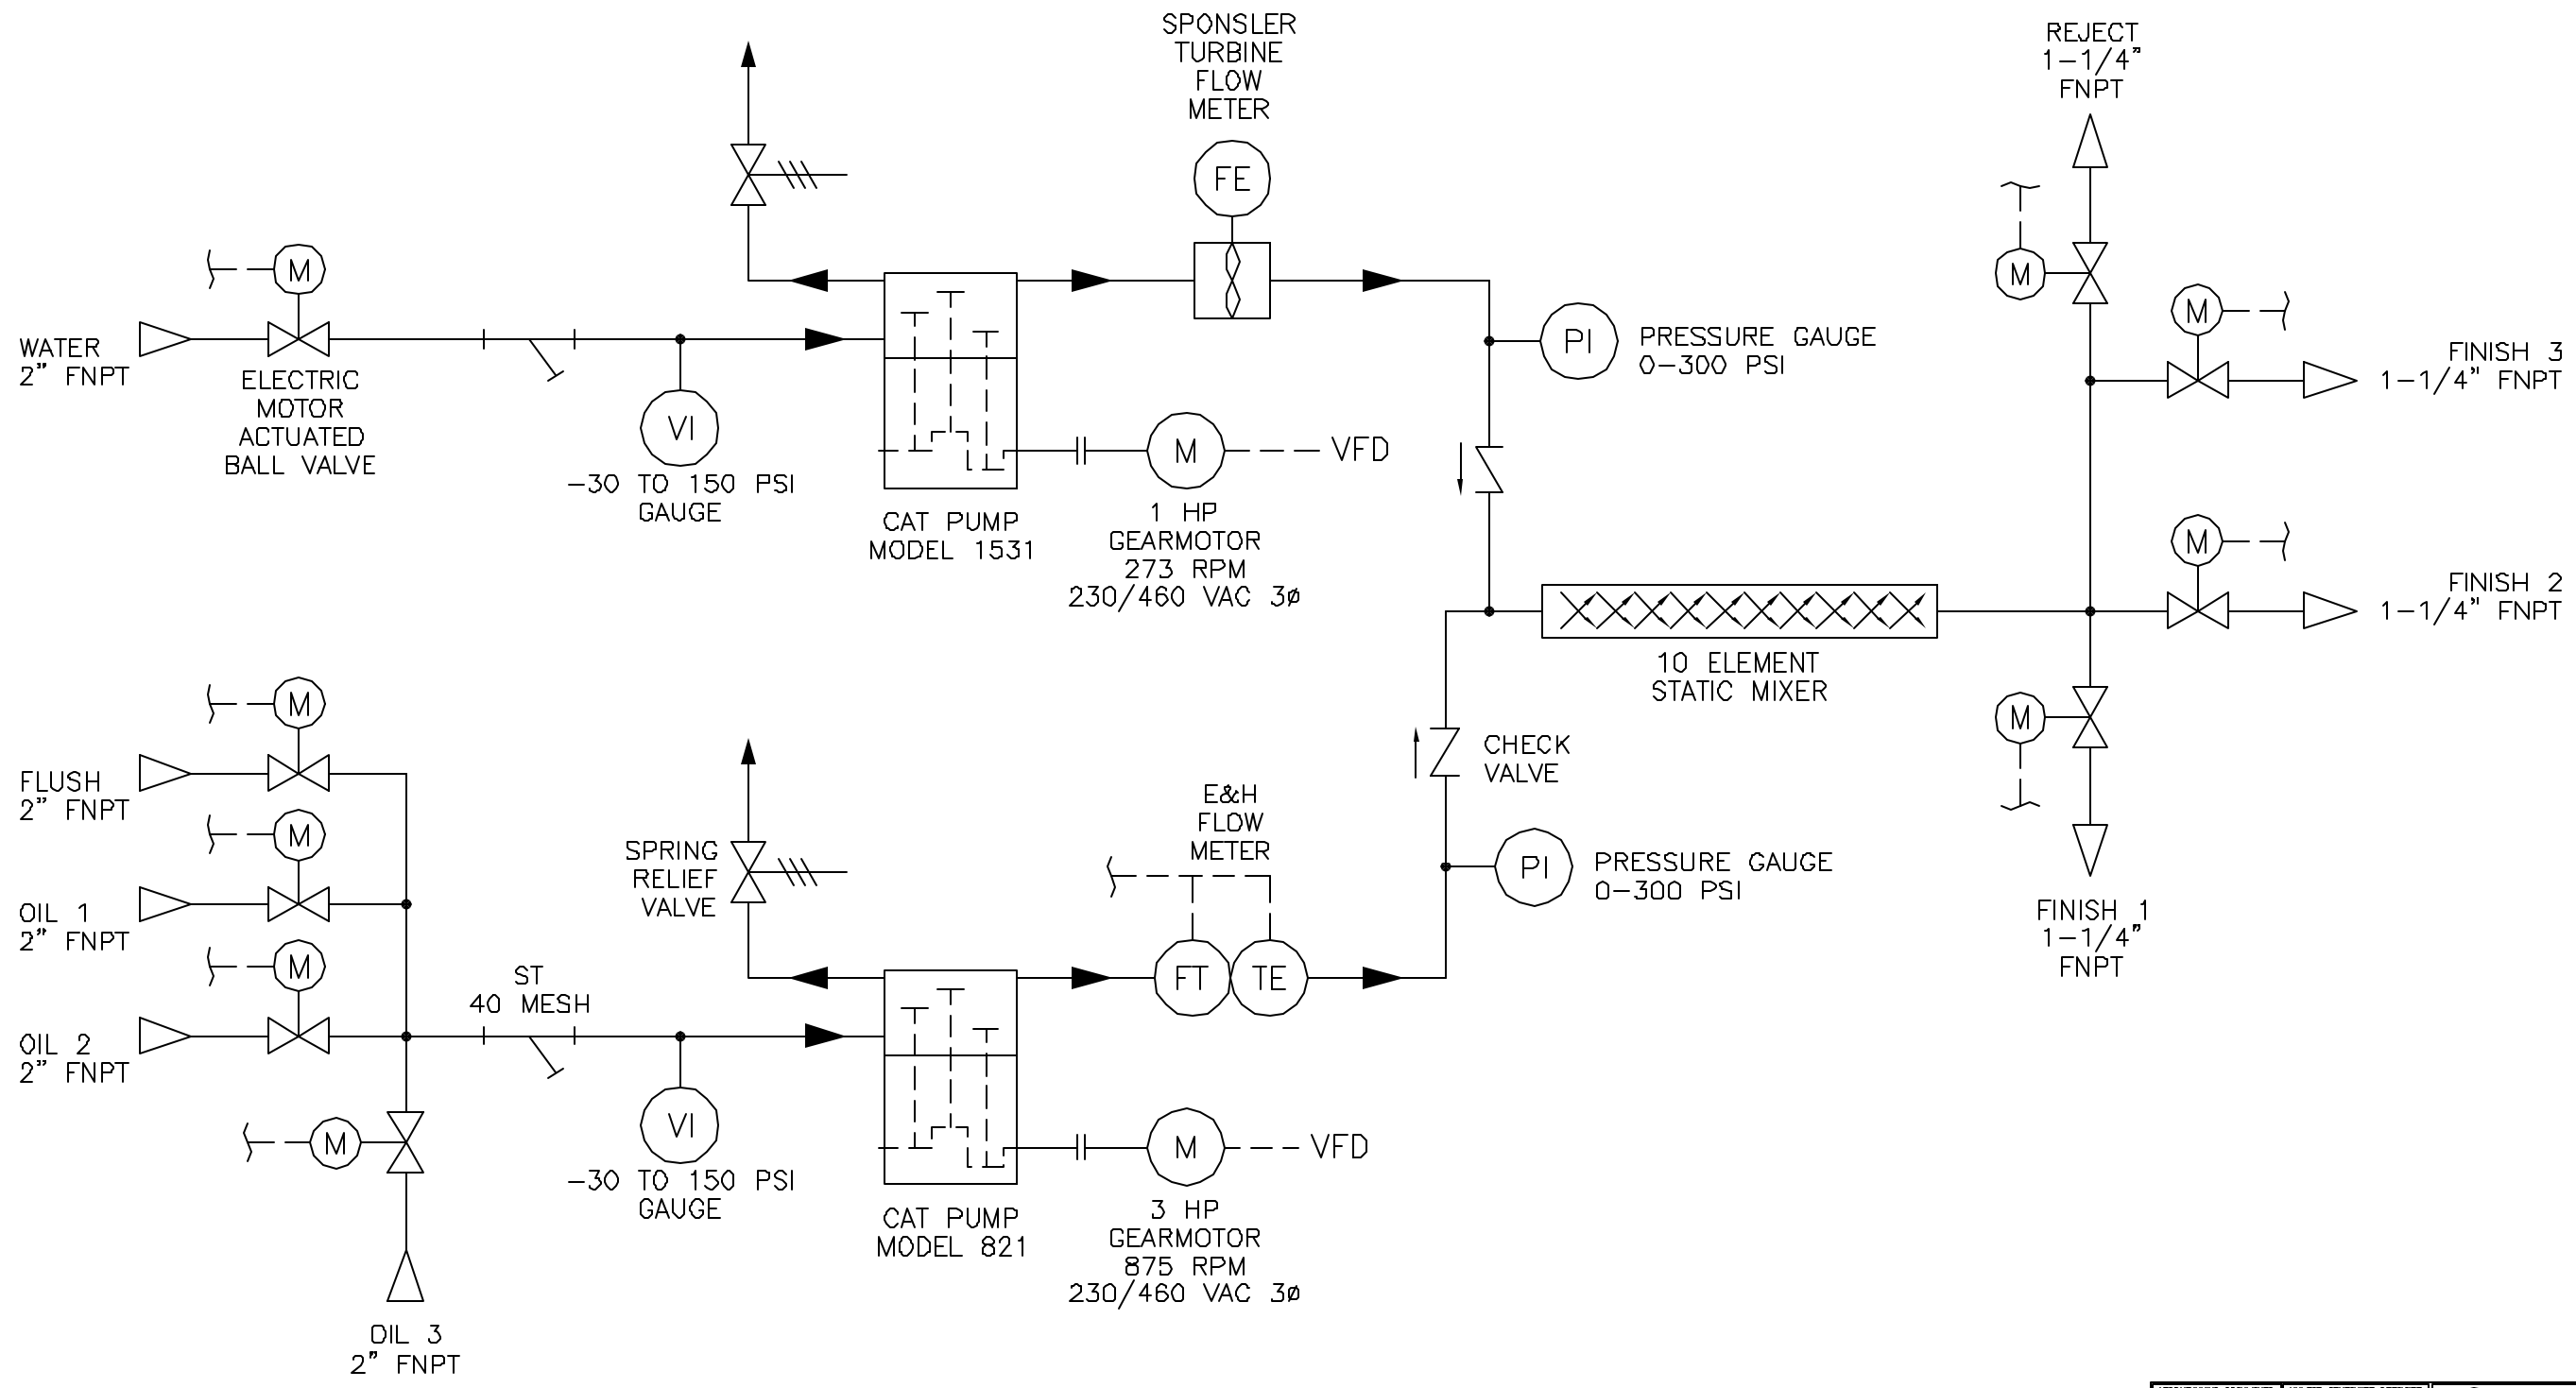

NOTES:

PROPRIETARY INFORMATION: THIS MATERIAL AND THE CONTENTS THEREOF ARE CONSIDERED THE PROPERTY OF SONIC CORPORATION AND ITS DESIGNEES. NO UNAUTHORIZED REPRODUCTION, PUBLICATION, OR CIRCULATION IS PERMITTED WITHOUT PRIOR WRITTEN CONSENT BY SONIC CORPORATION, STURROCK, CONNECTICUT.

ACCOMPANYING DOCUMENTS: COMMENTS, VENDOR NOTES	UNLESS OTHERWISE SPECIFIED DIMENSIONS ARE IN INCHES	1 Research Drive, Storford, CT 06265 203-375-0063 FAX 203-319-4079	
TOLERANCES	DECIMALS .XX ±	TITLE	
	FRACTIONS XXX ±	DUAL FEED TECHBLEND PRODUCTION SYSTEM P&ID DRAWING	
	ANGLES XXX ±	DRAWING NUMBER	
MATERIAL:	DRW R, CHKD	B/3/03	REV
FINISH:	DRW		A
HEAT TREAT:	APP		
SCALE 0.13 [DO NOT SCALE DRAWING]		SHEET 1 of 1	
GPO NUMBER \obj Prof\1829\1829-F-01-Adj.dwg			